


Farnsworth
 GROUP
 7707 N. KNOXVILLE AVE, SUITE 100
 PEORIA, ILLINOIS 61614
 (309) 689-9888 / (309) 689-9820 Fax

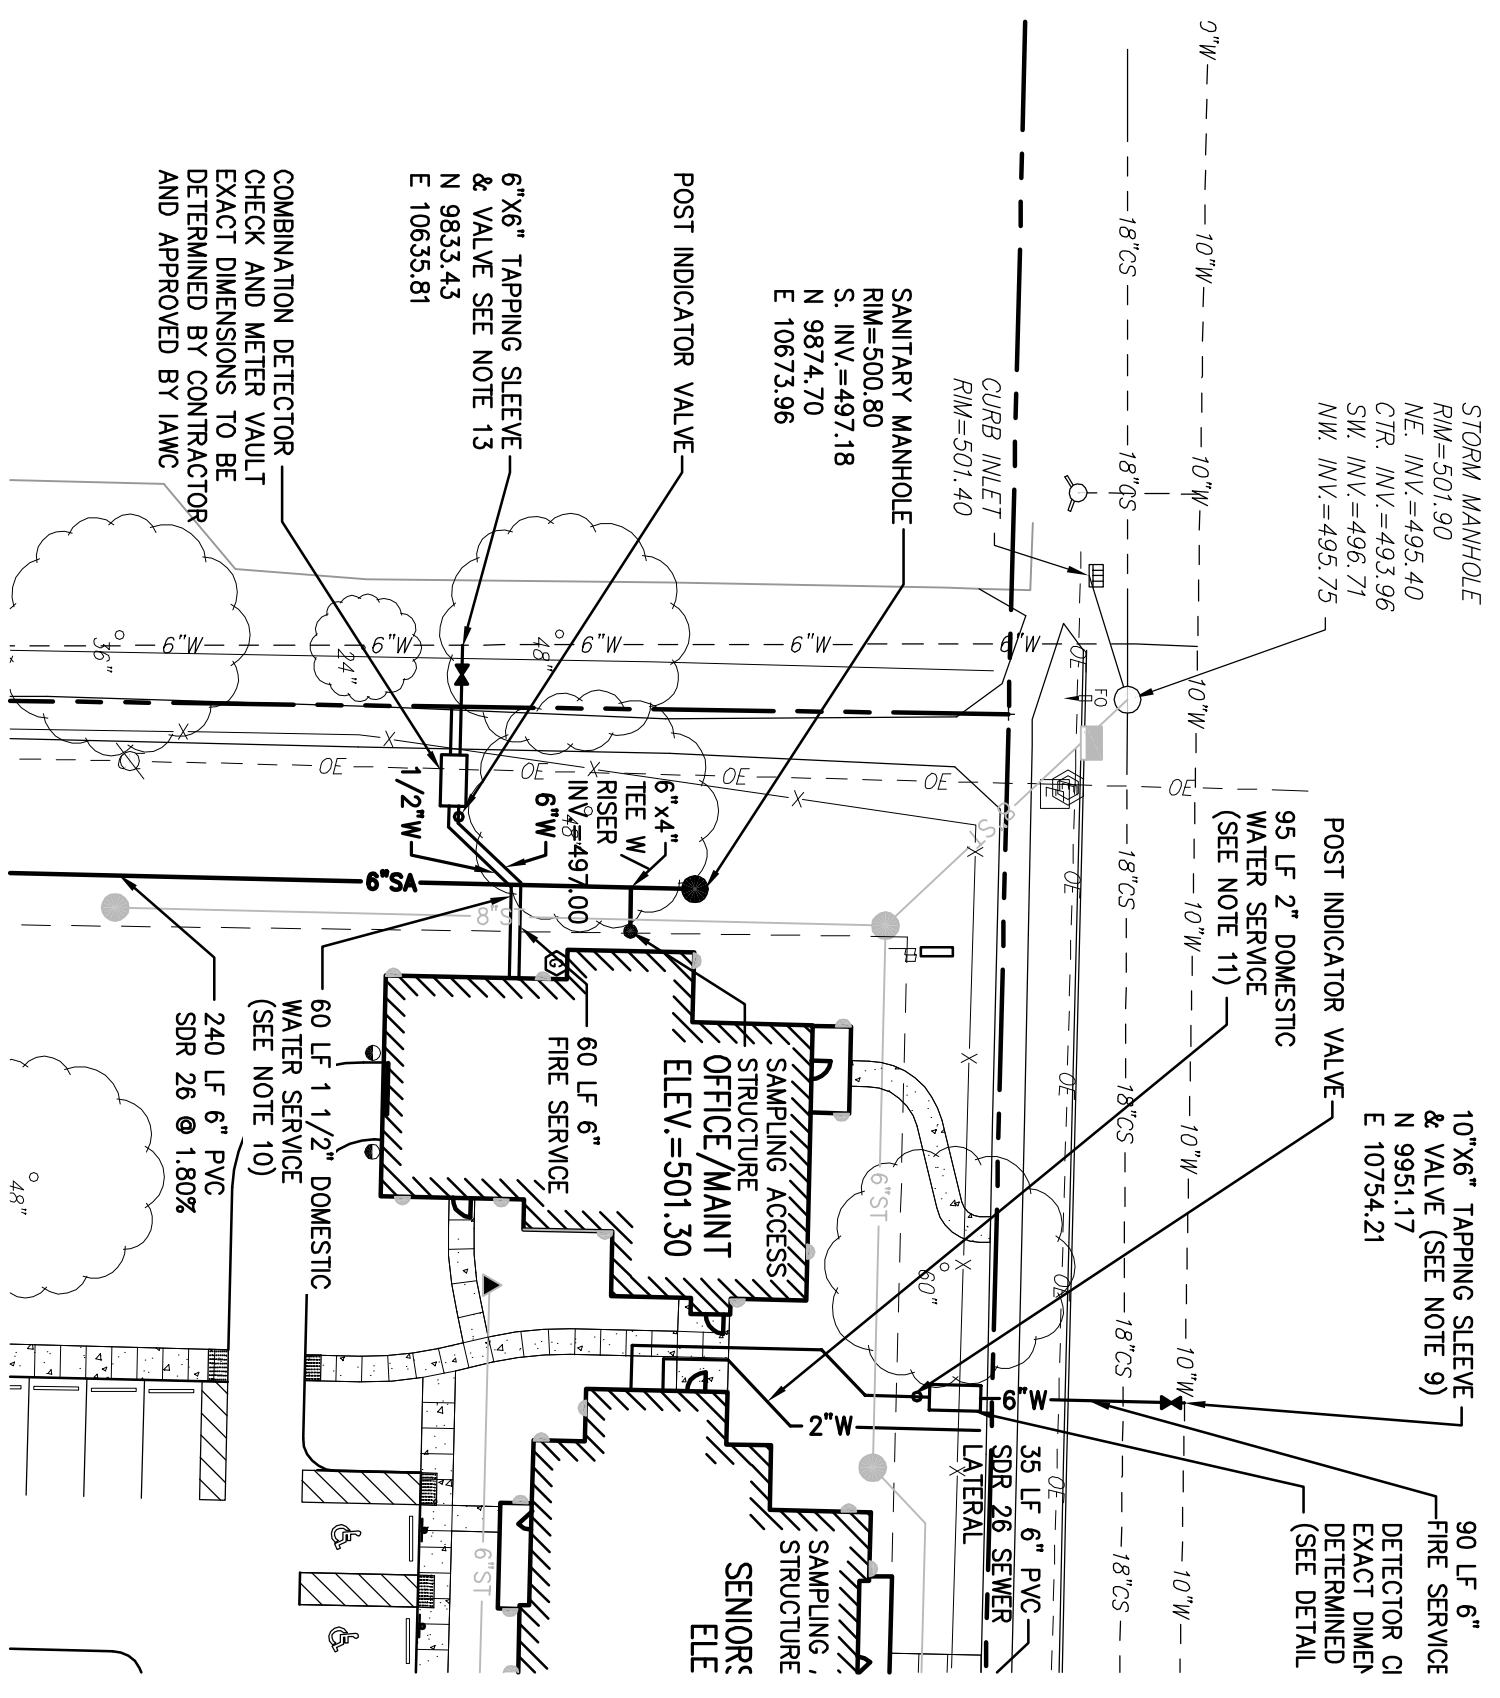

COMBINATION DETECTOR
 CHECK AND METER VAULT
 EXACT DIMENSIONS TO BE
 DETERMINED BY CONTRACTOR
 AND APPROVED BY IAWC

6"X6" TAPPING SLEEVE
 & VALVE SEE NOTE 13
 N 9833.43
 E 10635.81


SANITARY MANHOLE
 RIM=500.80
 S. INV.=497.18
 N 9874.70
 E 10673.96

STORM MANHOLE
 RIM=501.90
 NE. INV.=495.40
 CTR. INV.=493.96
 SW. INV.=496.71
 NW. INV.=495.75

10"X6" TAPPING SLEEVE
 & VALVE (SEE NOTE 9)
 N 9951.17
 E 10754.21

90 LF 6"
 FIRE SERVICE
 DETECTOR CI
 EXACT DIMEN
 DETERMINED
 (SEE DETAIL)

SUPPLEMENTAL DRAWING
 C3.0 SITE UTILITY PLAN
 HARRISON HOMES
 REDEVELOPMENT

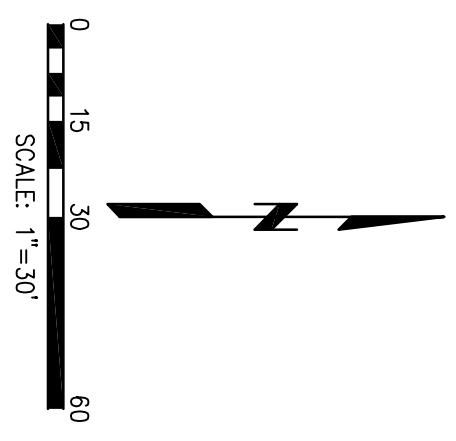

Project No: **0090282.00**
 Book No:
 Drawn by: **EMR**
 Reviewed: **LMT**
 Date:
SD01 (C3.0)